




THE UNIVERSITY OF  
**SCRANTON**  
A J E S U I T U N I V E R S I T Y

PHYSICAL PLANT  
DEPARTMENT  
SCRANTON, PA  
(570) 941-6267 PHONE  
(570) 941-6220 FAX

DeNAPLES CAMPUS CENTER

FOURTH FLOOR PLAN

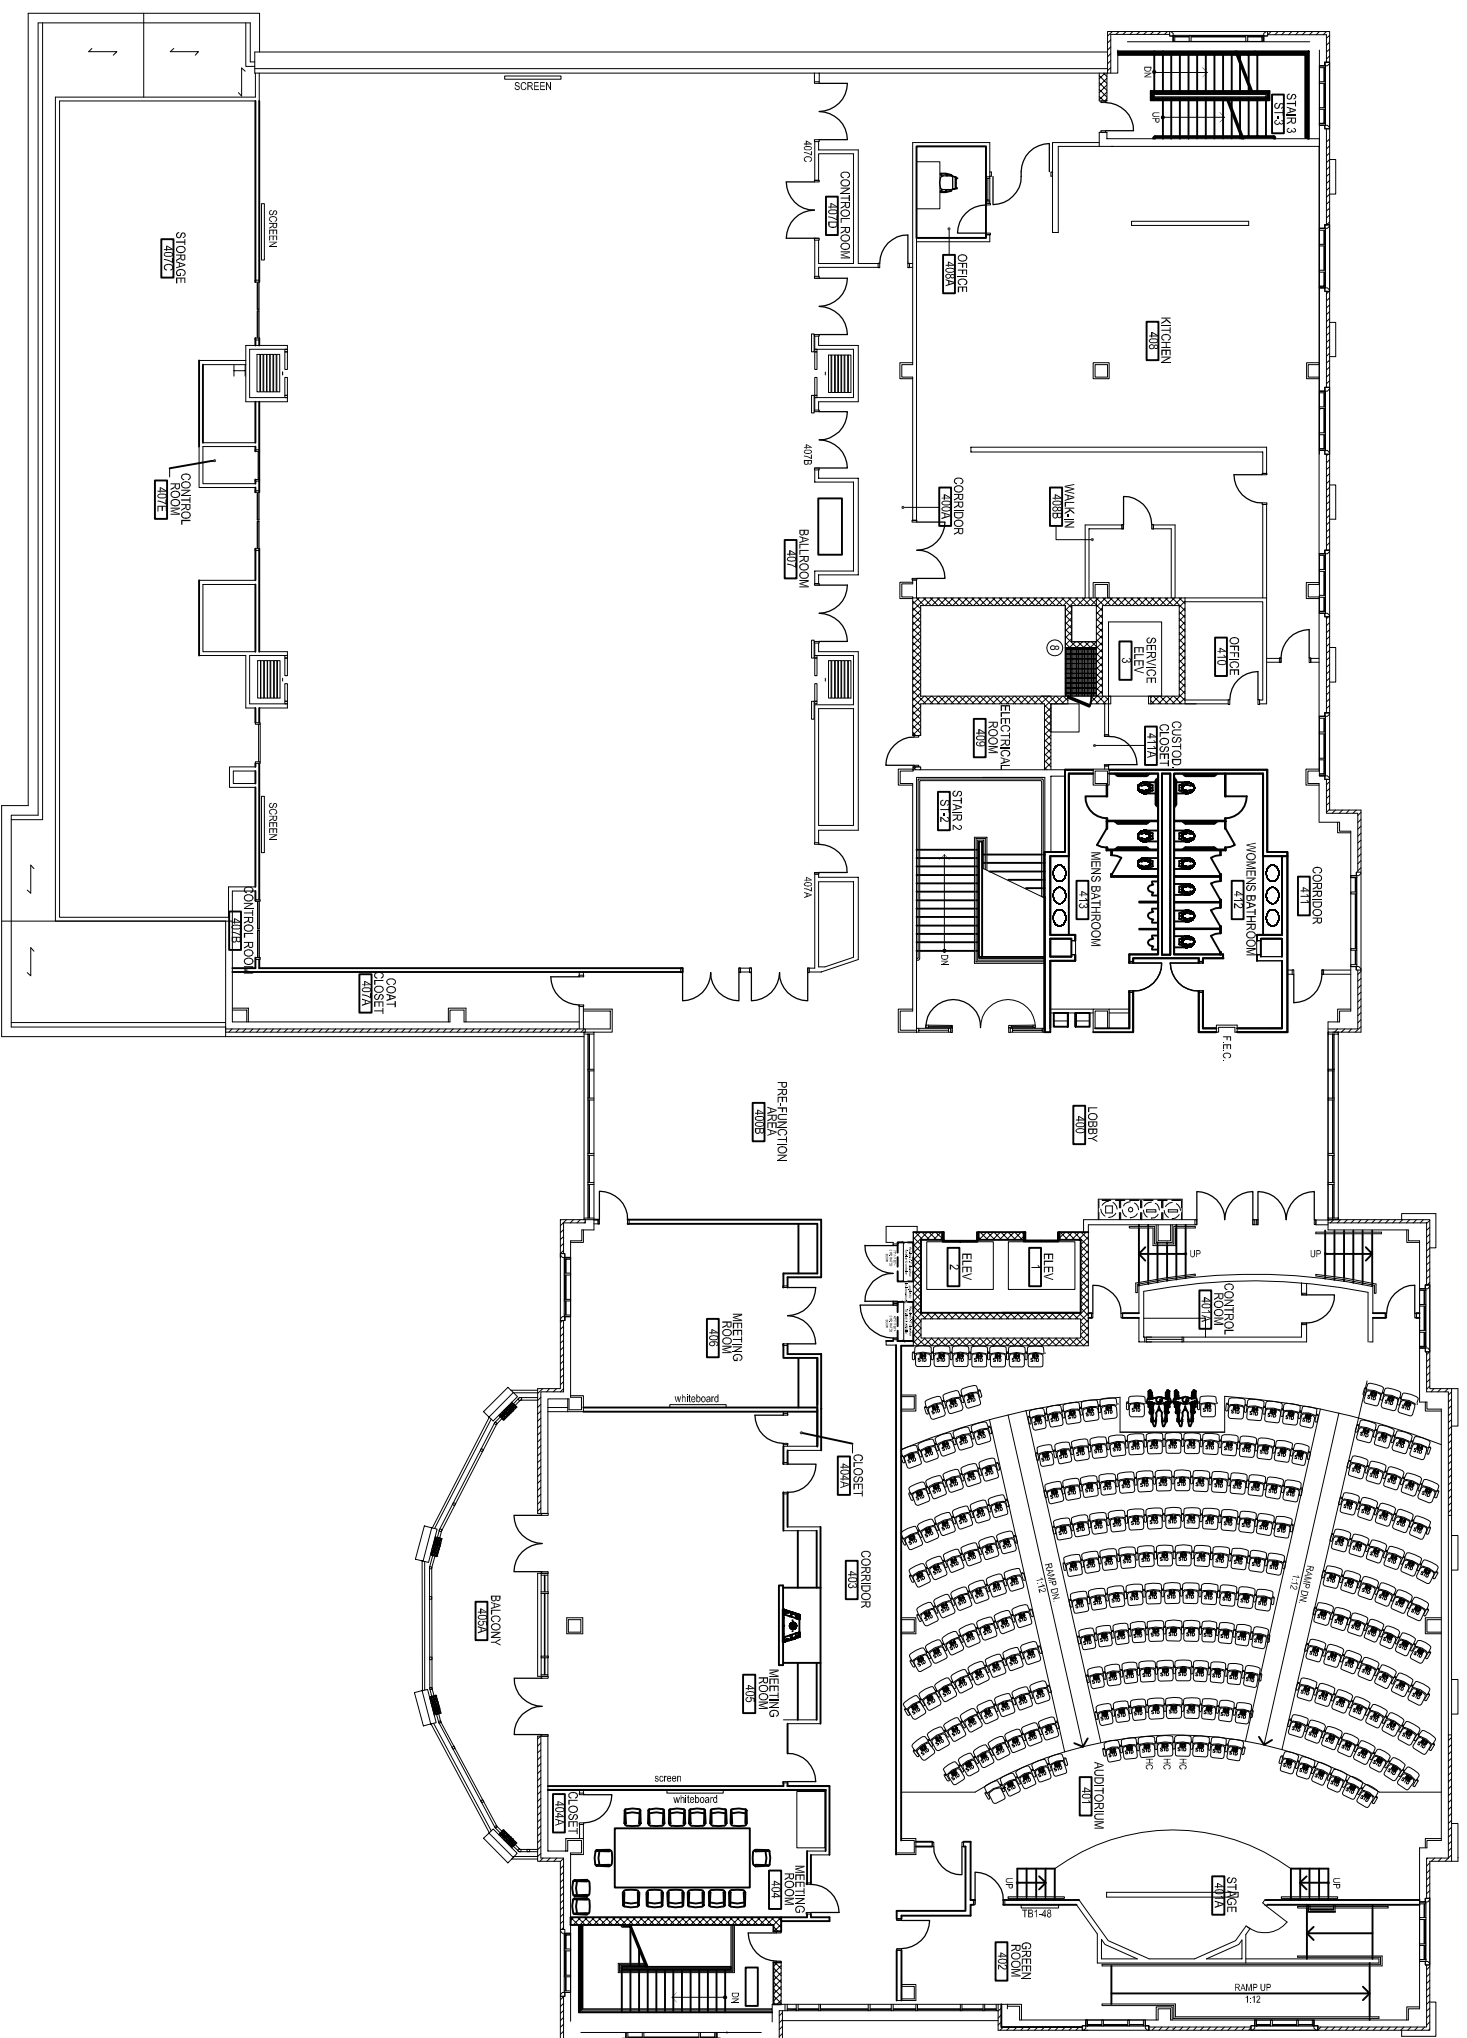

PROJECT NO.: -----  
DESIGNED: BURT-HILL  
DRAWN: KRANICK  
SCALE: 1" = 20'  
DATE: 6 AUG., 2007

DRAWING NO.  
899-004